



**REFLECTED CEILING**  
SCALE: 1/8" = 1'-0"

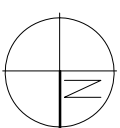

**FLOOR PLAN**  
SCALE: 1/8" = 1'-0"

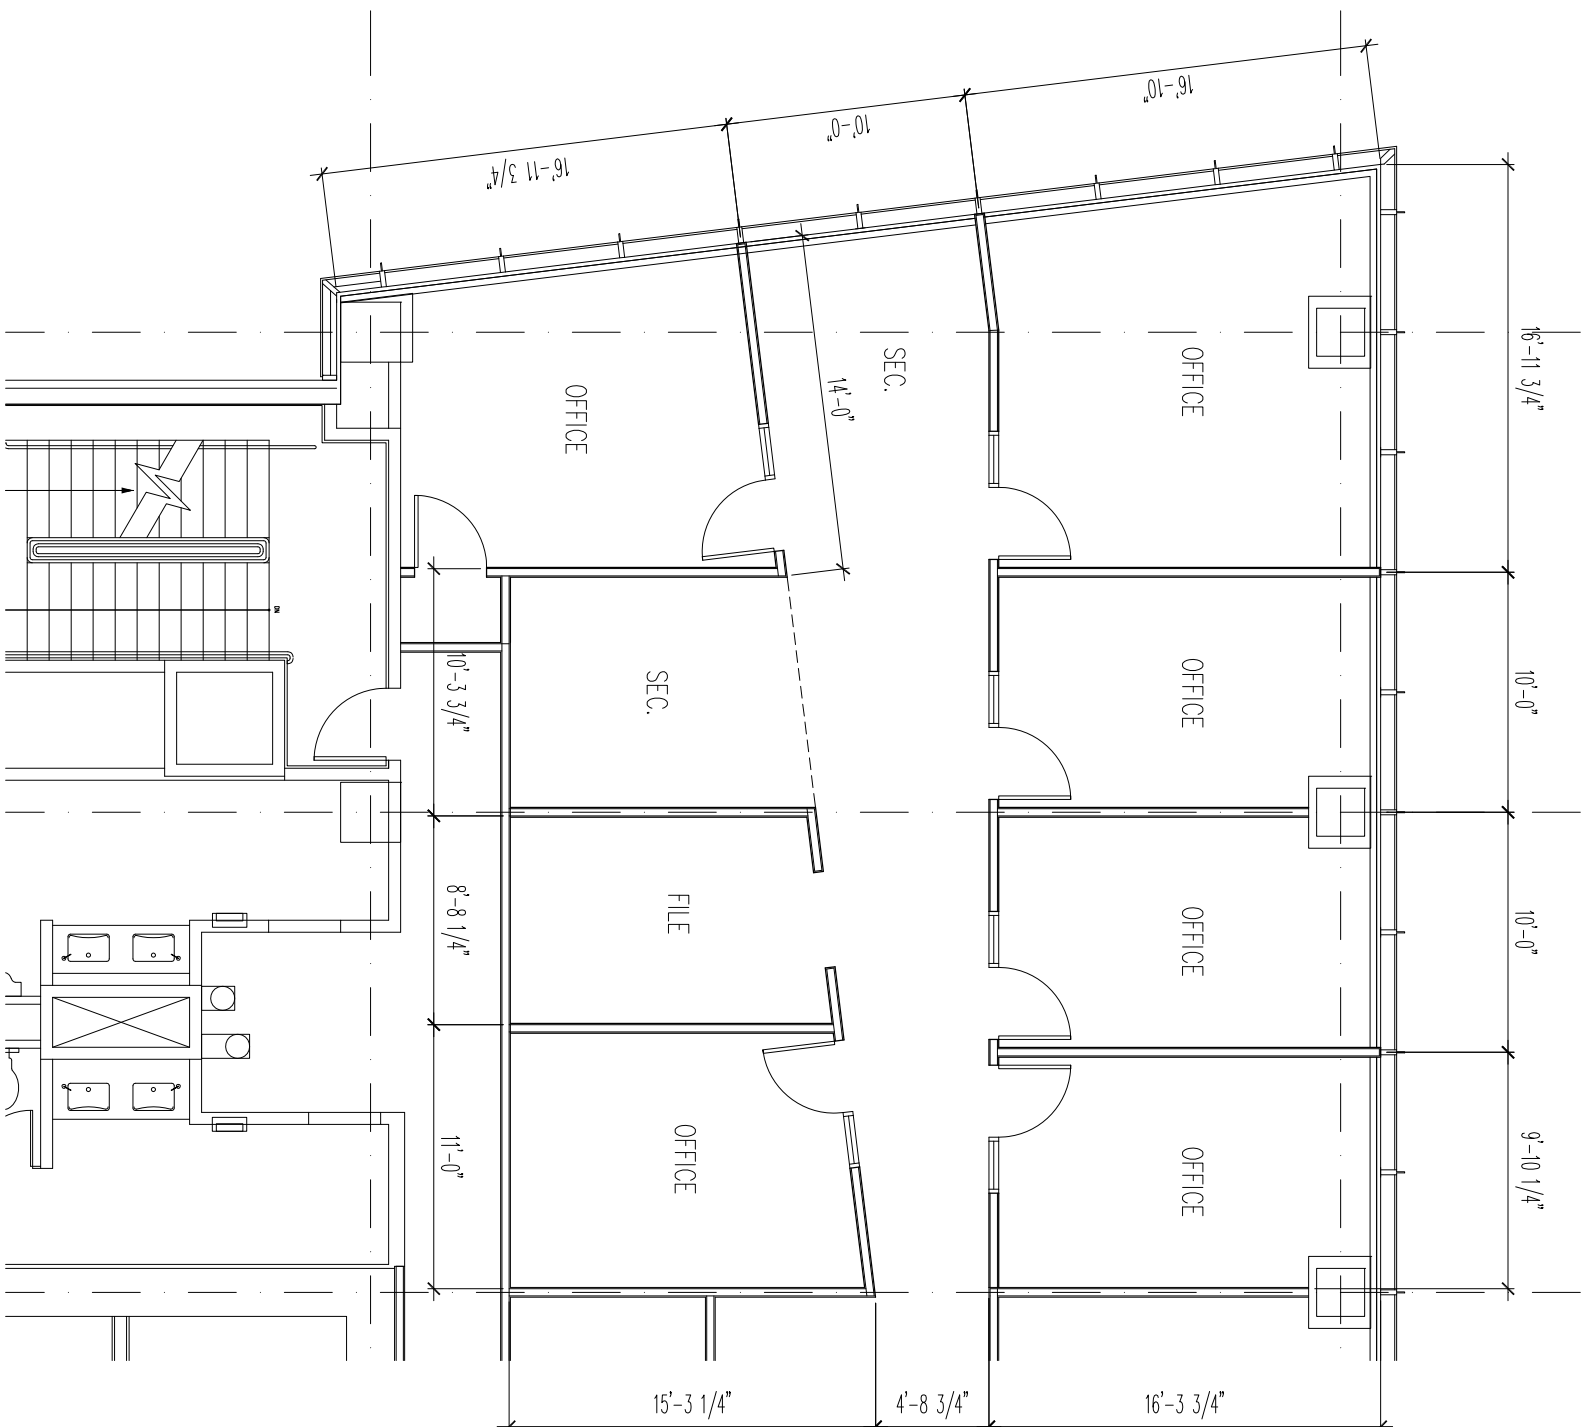

Project Number: 154185  
February 02, 2014

**Davis Wright Tremaine**  
188 West Northern Lights Blvd., 12th Floor  
Anchorage, Alaska 99503

**SK-1**